


Appendix L : Existing Utility Networks

DATE: 2016-07-26 - 2:47pm (ISLAF)
 PATH: \\s0262\Project\DATA\Airport Group\Projects\627320 - YLW Master Plan\4-ENG\4T_AIRPORT PLANNING\DK_SKETCHES\AD DRAWINGS\MASTER PLAN UPDATE\627320-0000-40DK-0020 TO 0024.d
 LAYOUT: 0020

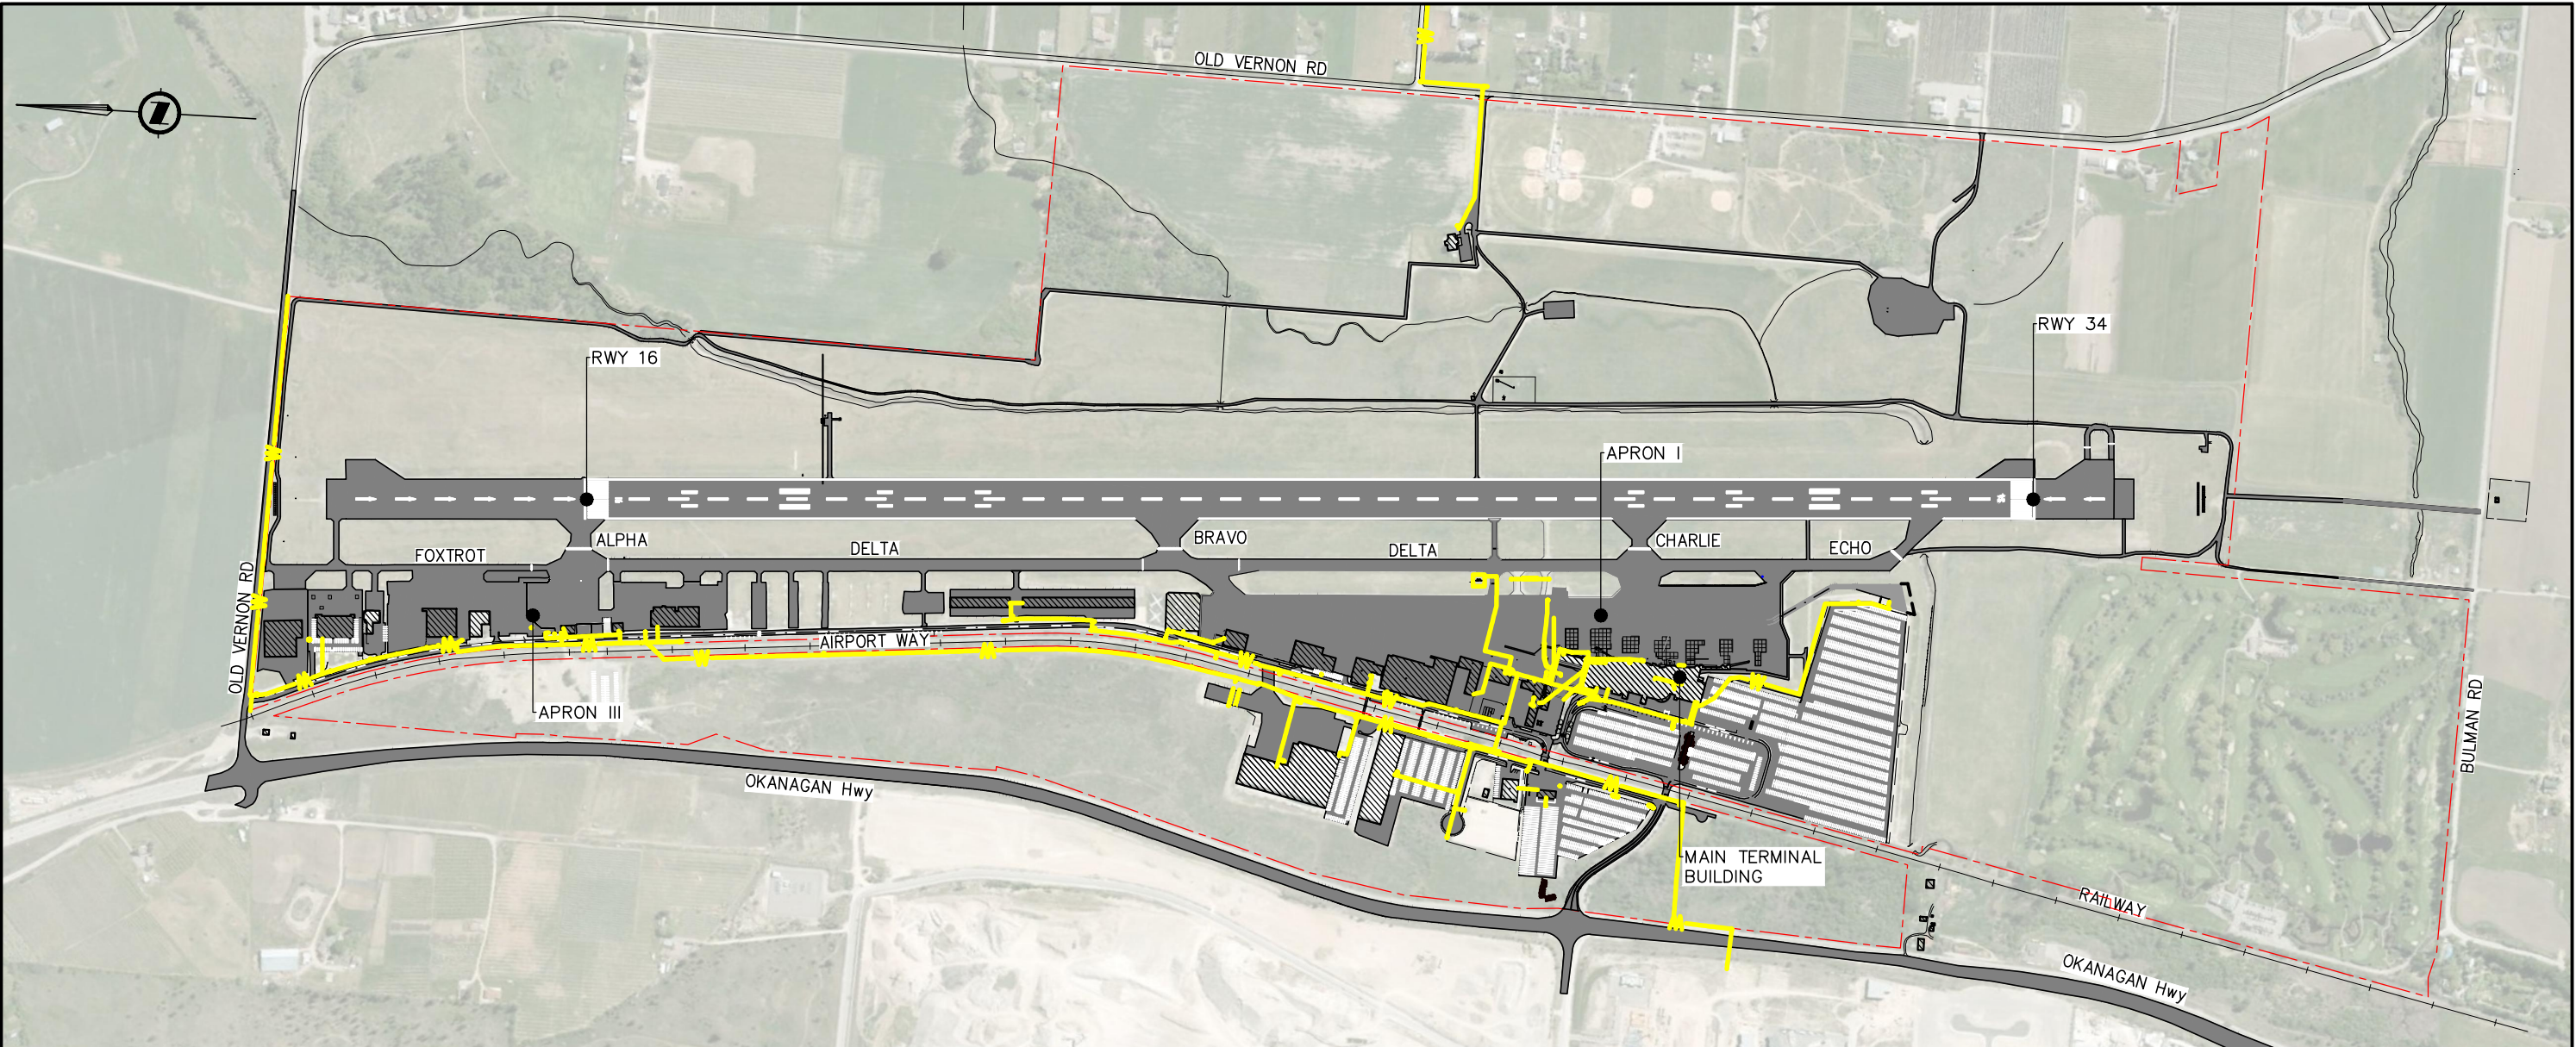

- LEGEND**
- PAVEMENTS
 - BUILDING STRUCTURE
 - AIRPORT BOUNDARY
 - WATER LINE

SCALE 1:10 000
@11x17

ISSUE No	REV.	DATE (Y/M/D)	PURPOSE OF ISSUE	No	REVISION DESCRIPTION	DATE (Y/M/D)	*	**
1	PA	2016-07-21	ISSUED FOR INFORMATION					

ISSUE REGISTER	REVISION REGISTER	* DESIGNED	** APPROVED

PROFESSIONAL SEAL


SNC-LAVALIN
Airports & Aviation Group
500-745 Thurlow Street, Vancouver British Columbia, Canada. V6E 1V8
Tel: 604-662-3555

YLW
Kelowna International Airport

DESIGNED	
DRAWN	
CHECKED	
APPROVED	
DATE	2016-07-21
SCALE	1:10 000

PROJECT YLW MASTER PLAN				
TITLE WATER SERVICES LAYOUT				
PROJECT No	SUBDIVISION	SUBJECT	SERIAL	REV.
627320	0000	40DK	0020	PA

DATE: 2016-07-26 - 2:48pm (ISLAF)
 PATH: \\s0262\Project\DATA\Airport Group\Projects\627320 - YLW Master Plan\4-ENG\4T_AIRPORT PLANNING\DK_SKETCHES\AD DRAWINGS\MASTER PLAN UPDATE\627320-0000-40DK-0020 TO 0024.d
 LAYOUT: 0021

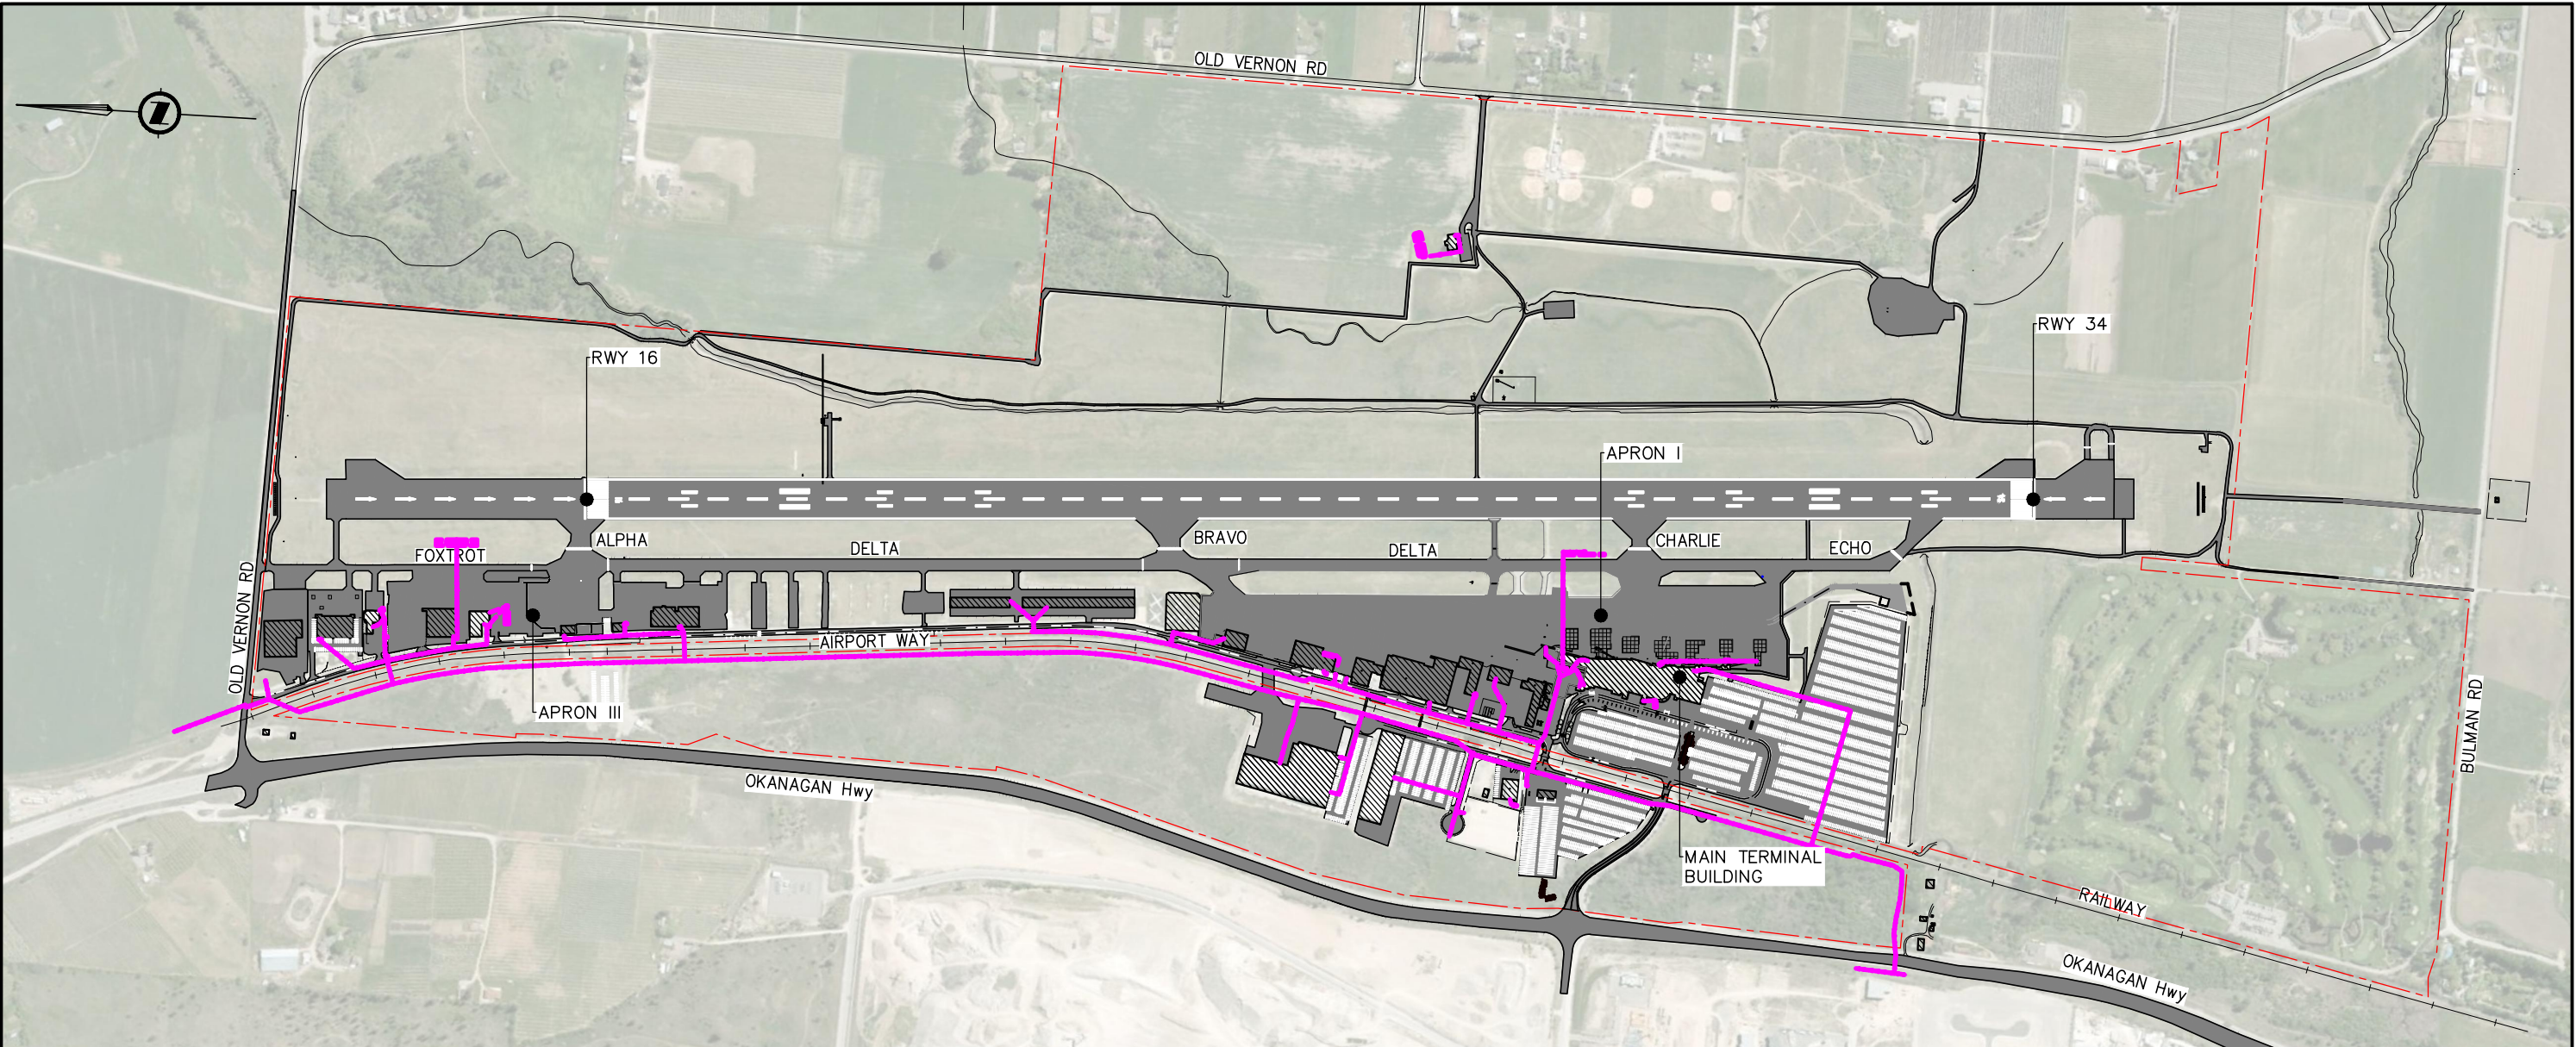

- LEGEND**
- PAVEMENTS
 - BUILDING STRUCTURE
 - AIRPORT BOUNDARY
 - SANITARY LINE

SCALE 1:10 000
@11x17

ISSUE No	REV.	DATE (Y/M/D)	PURPOSE OF ISSUE	No	REVISION DESCRIPTION	DATE (Y/M/D)	*	**
1	PA	2016-07-21	ISSUED FOR INFORMATION					
ISSUE REGISTER				REVISION REGISTER * DESIGNED ** APPROVED				

PROFESSIONAL SEAL


SNC-LAVALIN
Airports & Aviation Group
500-745 Thurlow Street, Vancouver British Columbia, Canada. V6E 1V8
Tel: 604-662-3555

YLW
Kelowna International Airport

DESIGNED
DRAWN
CHECKED
APPROVED
DATE 2016-07-21
SCALE 1:10 000

PROJECT YLW MASTER PLAN				
TITLE SANITARY SERVICES LAYOUT				
PROJECT No	SUBDIVISION	SUBJECT	SERIAL	REV.
627320	0000	40 DK	0021	PA

DATE: 2016-07-26 - 2:53pm (ISLAF)
 PATH: \\s0262\Project\DATA\Airport Group\Projects\627320 - YLW Master Plan\4-ENG\4T_AIRPORT PLANNING\DK_SKETCHES\AD DRAWINGS\MASTER PLAN UPDATE\627320-0000-40DK-0020 TO 0024.d
 LAYOUT: 0022

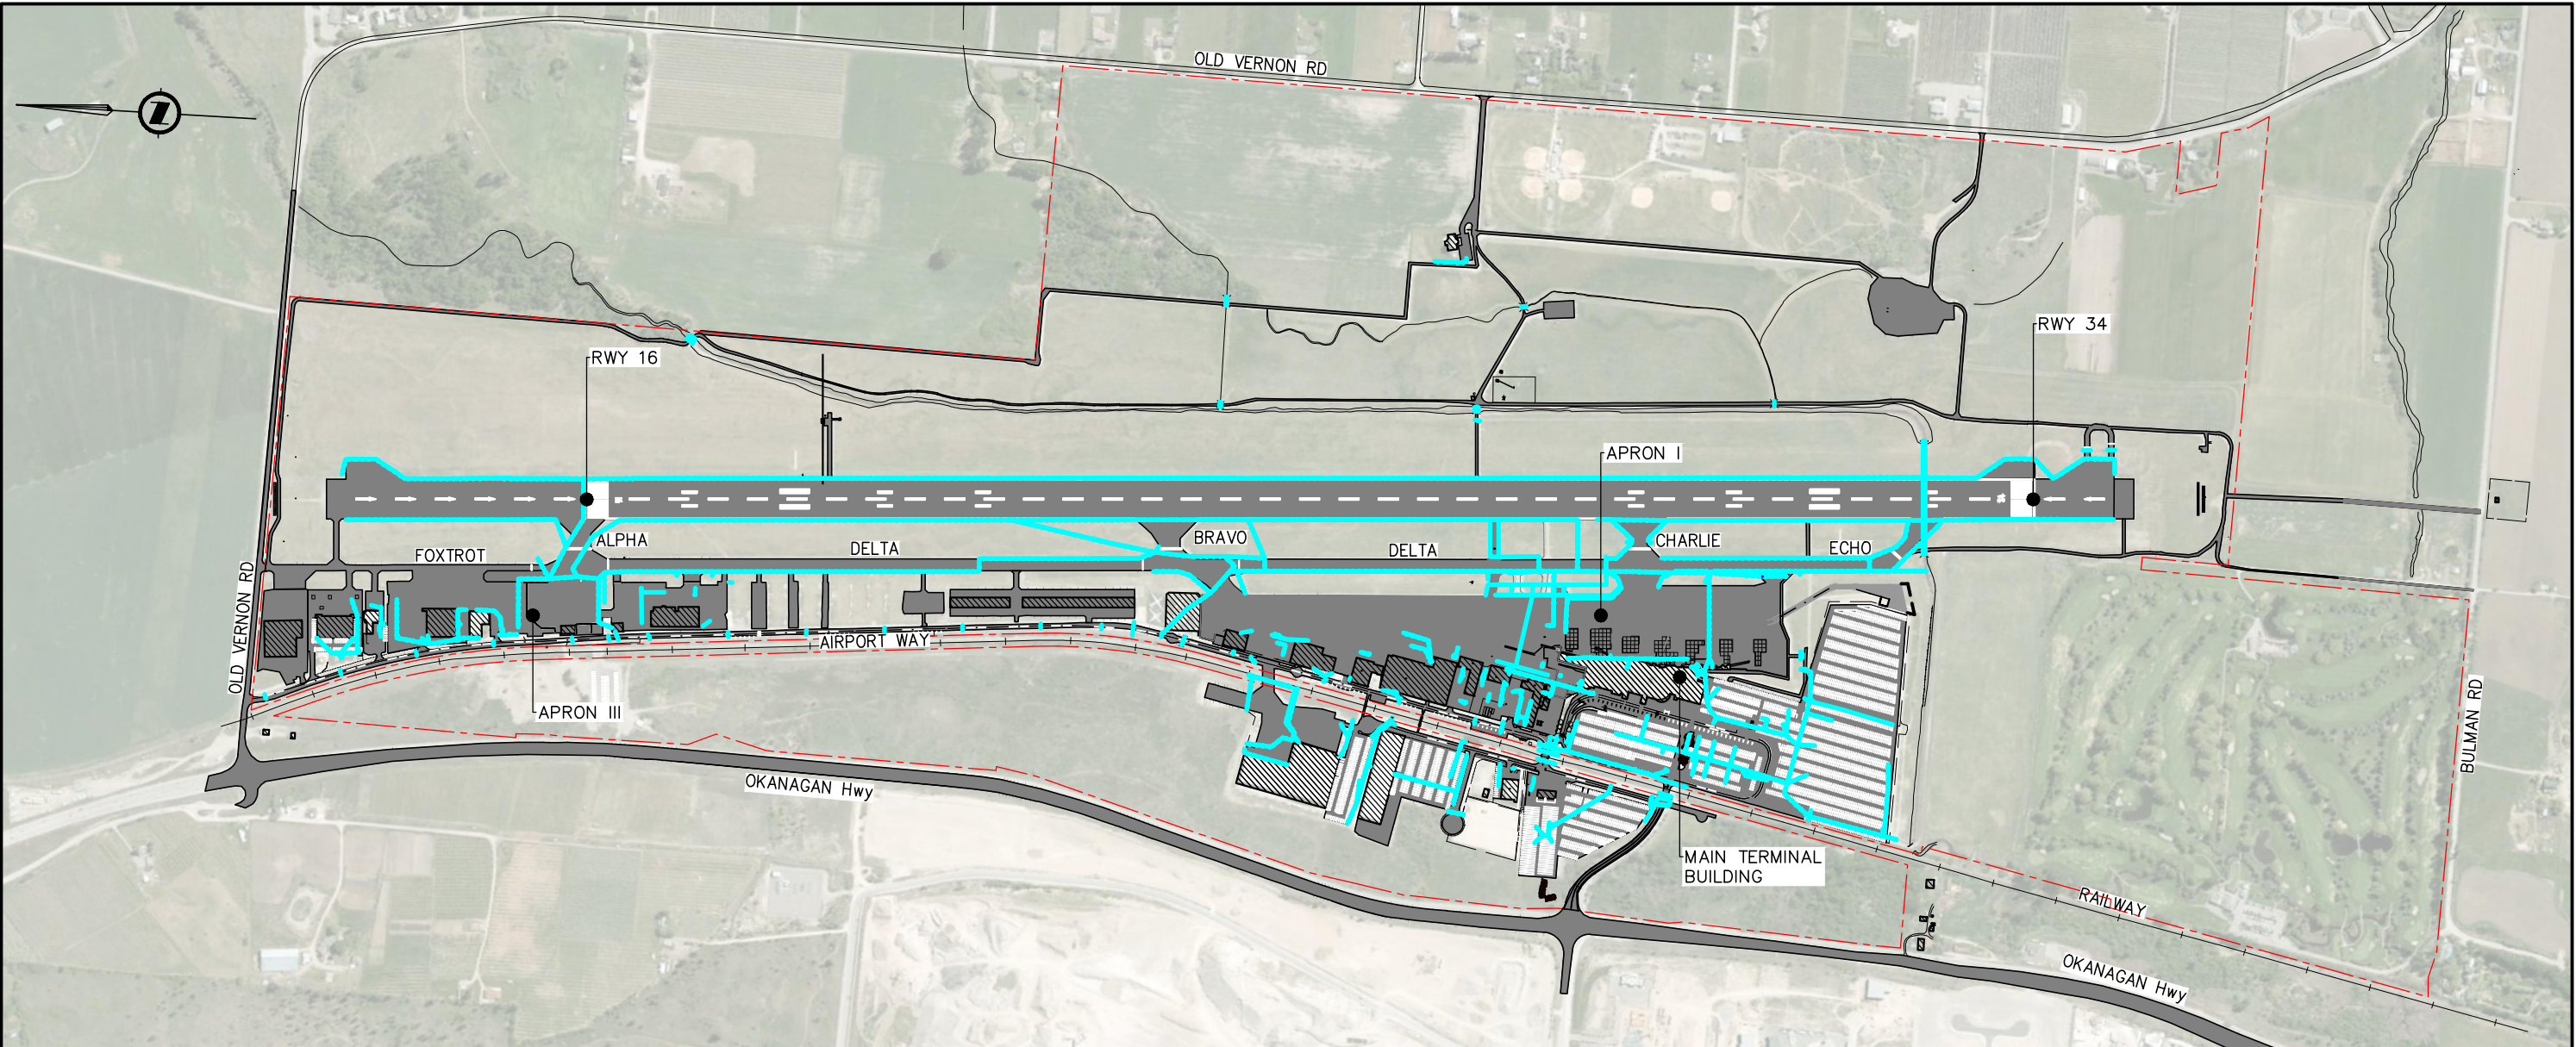

- LEGEND**
- PAVEMENTS
 - BUILDING STRUCTURE
 - AIRPORT BOUNDARY
 - STORM DRAINAGE LINE

SCALE 1:10 000
 @11x17
 0 200 500m

ISSUE No	REV.	DATE (Y/M/D)	PURPOSE OF ISSUE	No	REVISION DESCRIPTION	DATE (Y/M/D)	*	**
1	PA	2016-07-21	ISSUED FOR INFORMATION					
ISSUE REGISTER				REVISION REGISTER * DESIGNED ** APPROVED				

PROFESSIONAL SEAL

SNC-LAVALIN
 Airports & Aviation Group
 500-745 Thurlow Street, Vancouver British Columbia, Canada. V6E 1V8
 Tel: 604-662-3555


CLIENT

YLW
 Kelowna International Airport

DESIGNED
DRAWN
CHECKED
APPROVED
DATE 2016-07-21
SCALE 1:10 000

PROJECT YLW MASTER PLAN				
TITLE STORM DRAINAGE LAYOUT				
PROJECT No	SUBDIVISION	SUBJECT	SERIAL	REV.
627320	0000	40DK	0022	PA

DATE: 2016-07-26 - 2:54pm (ISLAF)
 PATH: \\sio0262\Project\DATA\Airport Group\Projects\627320 - YLW Master Plan\4-ENG\4T_AIRPORT PLANNING\DK_SKETCHES\AD DRAWINGS\MASTER PLAN UPDATE\627320-0000-40DK-0020 TO 0024.d
 LAYOUT: 0023

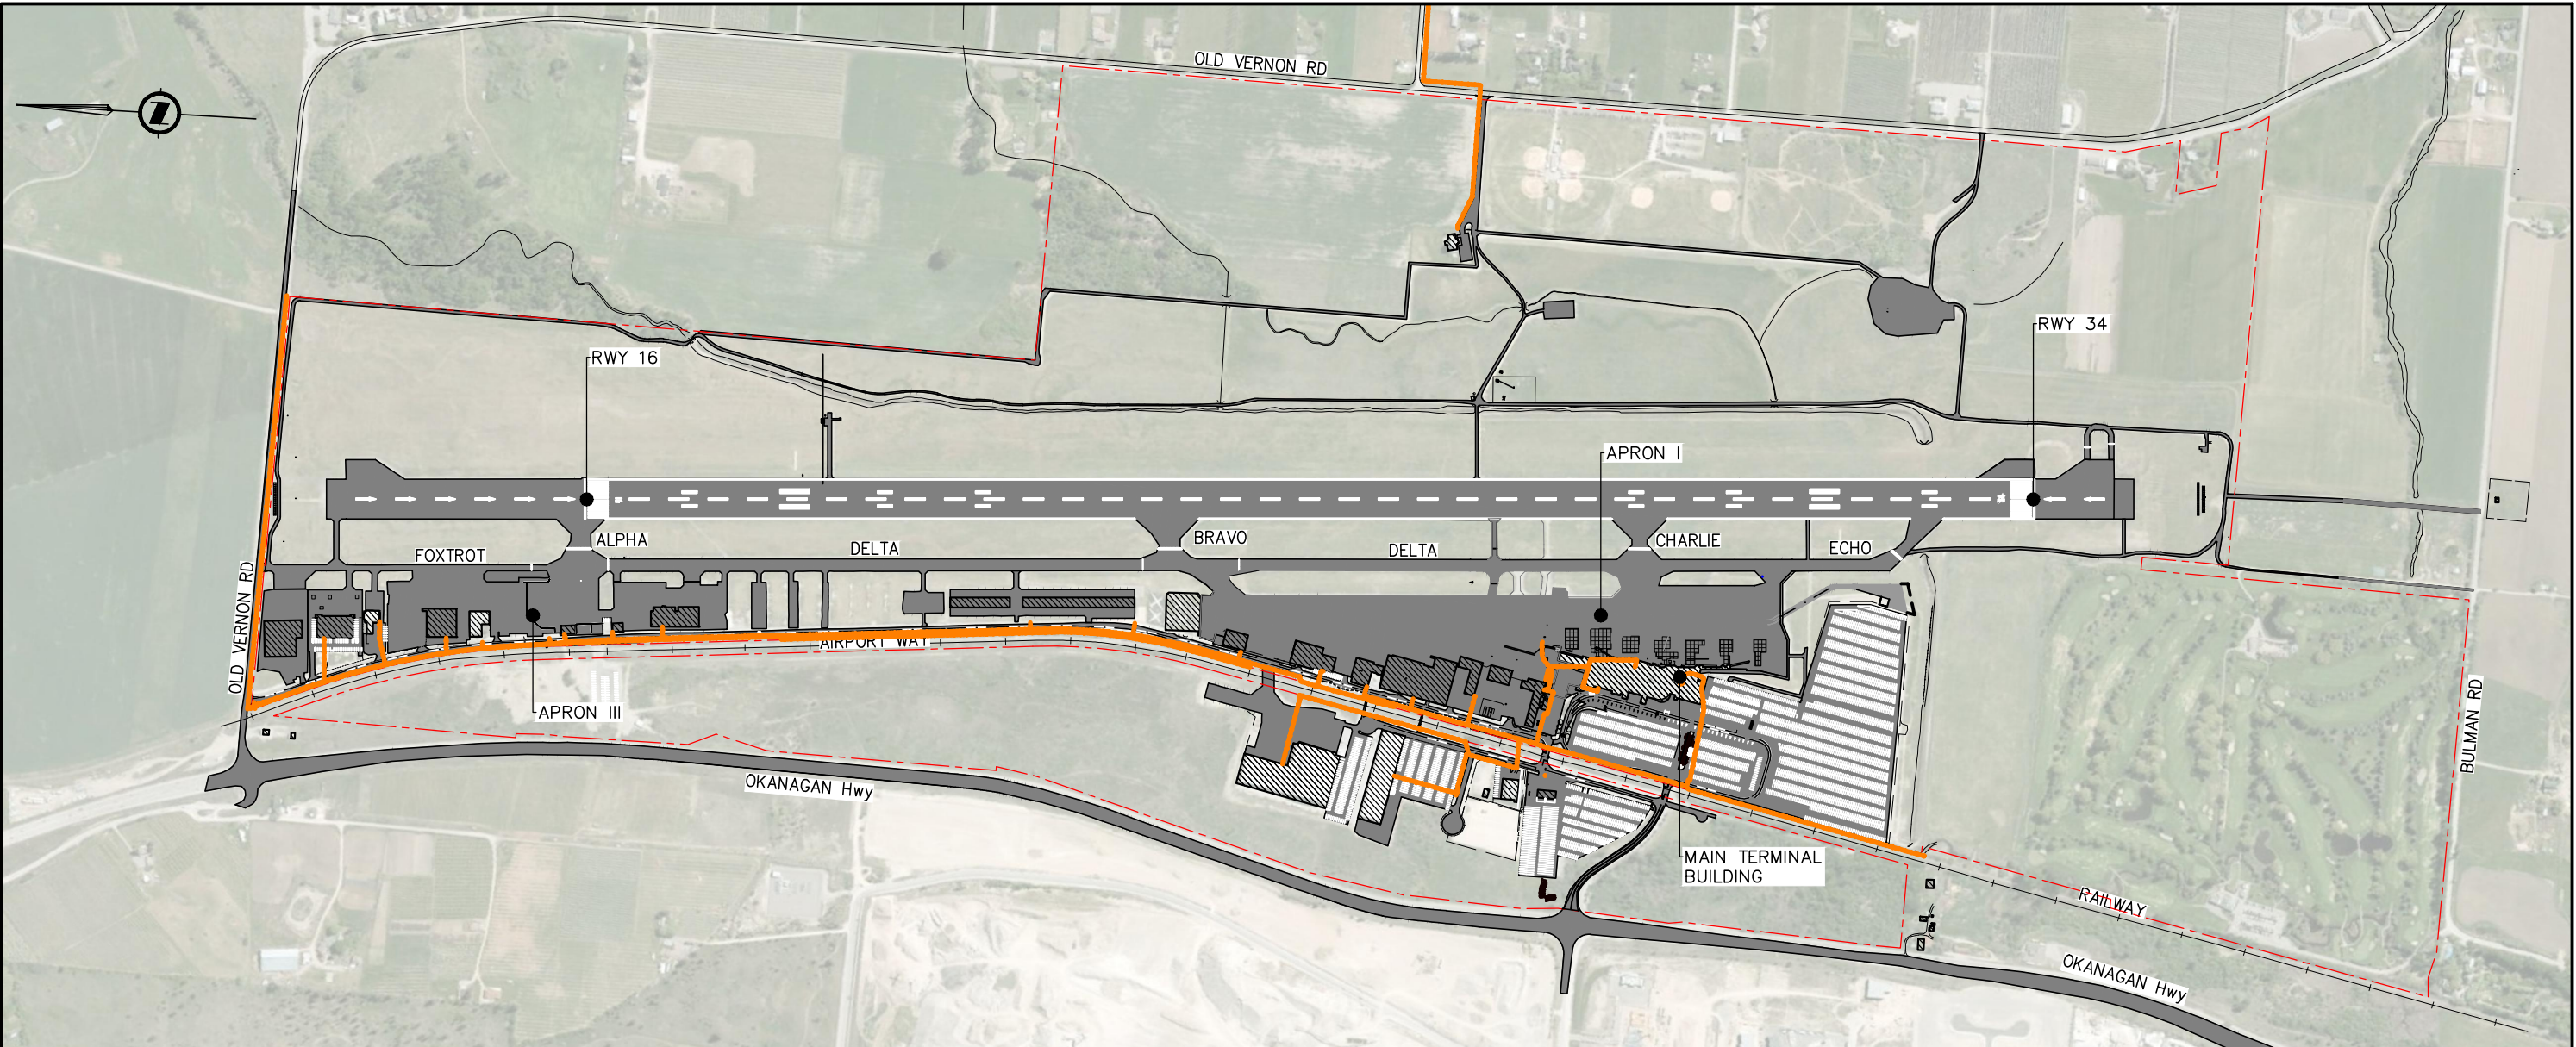

- LEGEND**
- PAVEMENTS
 - BUILDING STRUCTURE
 - AIRPORT BOUNDARY
 - GAS LINE

SCALE 1:10 000
@11x17

ISSUE No	REV.	DATE (Y/M/D)	PURPOSE OF ISSUE	No	REVISION DESCRIPTION	DATE (Y/M/D)	*	**
1	PA	2016-07-21	ISSUED FOR INFORMATION					

ISSUE REGISTER	REVISION REGISTER	* DESIGNED	** APPROVED

PROFESSIONAL SEAL


SNC-LAVALIN
Airports & Aviation Group
500-745 Thurlow Street, Vancouver British Columbia, Canada. V6E 1V8
Tel: 604-662-3555

YLW
Kelowna International Airport


DESIGNED	
DRAWN	
CHECKED	
APPROVED	
DATE	2016-07-21
SCALE	1:10 000

PROJECT YLW MASTER PLAN				
TITLE GAS SERVICES LAYOUT				
PROJECT No	SUBDIVISION	SUBJECT	SERIAL	REV.
627320	0000	40DK	0023	PA

DATE: 2016-07-26 - 2:56pm (ISLAF)
 PATH: \\s0262\Project\DATA\Airport Group\Projects\627320 - YLW Master Plan\4-ENG\4T_AIRPORT PLANNING\DK_SKETCHES\AD DRAWINGS\MASTER PLAN UPDATE\627320-0000-40DK-0020 TO 0024.d
 LAYOUT: 0024

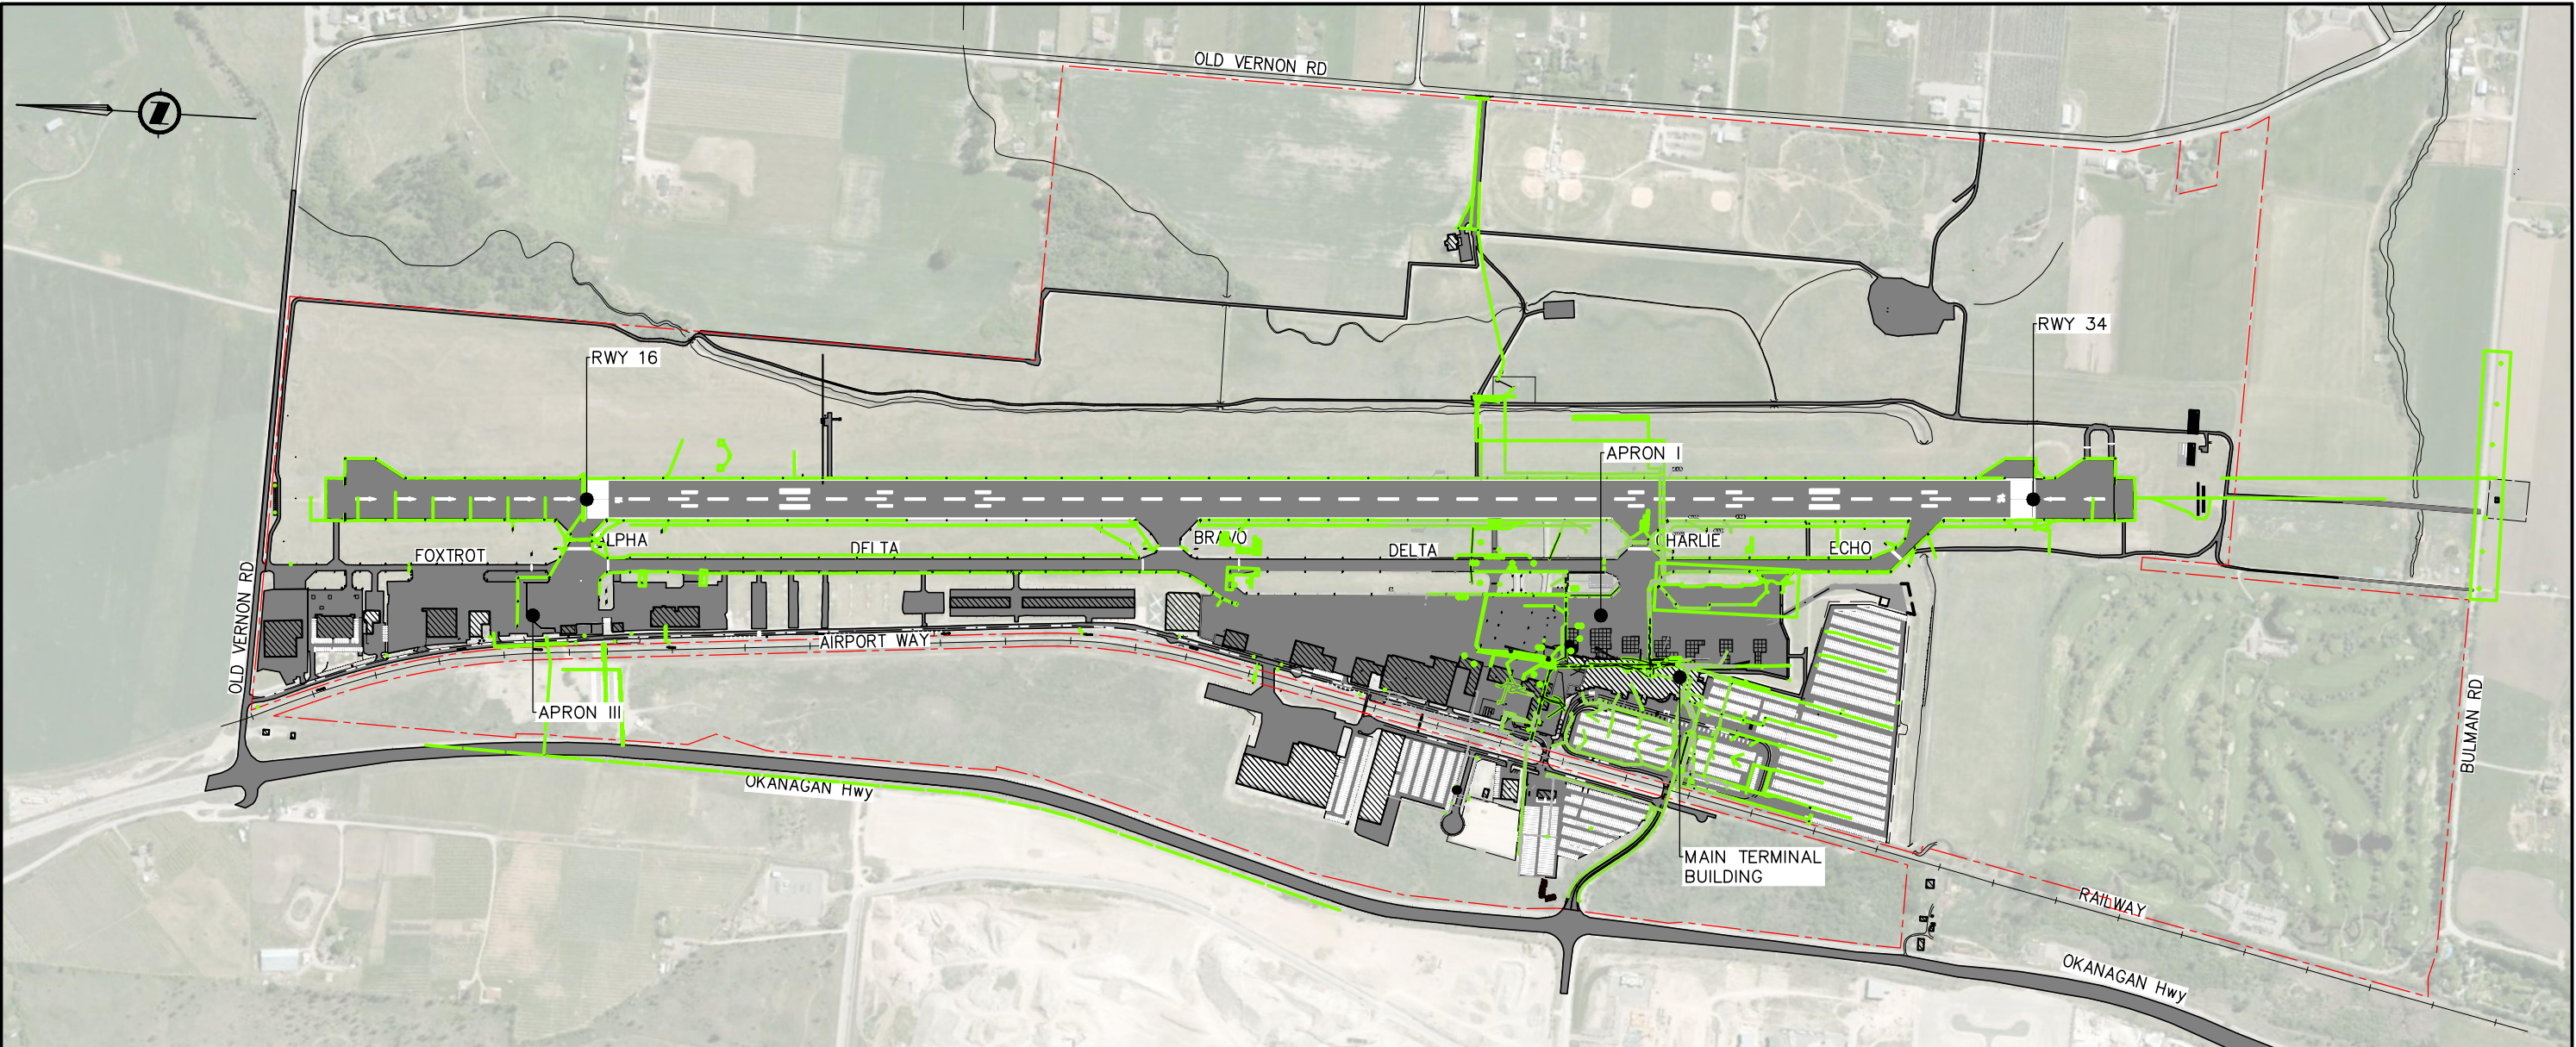

 - LEGEND**
- PAVEMENTS
 - BUILDING STRUCTURE
 - AIRPORT BOUNDARY
 - POWER AND TELECOM LINE



ISSUE No	REV.	DATE (Y/M/D)	PURPOSE OF ISSUE	No	REVISION DESCRIPTION	DATE (Y/M/D)	*	**
1	PA	2016-07-21	ISSUED FOR INFORMATION					
			ISSUE REGISTER	REVISION REGISTER			* DESIGNED	** APPROVED

PROFESSIONAL SEAL

SNC-LAVALIN
Airports & Aviation Group
500-745 Thurlow Street, Vancouver British Columbia, Canada. V6E 1V8
Tel: 604-662-3555

CLIENT

DESIGNED
DRAWN
CHECKED
APPROVED
DATE 2016-07-21
SCALE 1:10 000

PROJECT YLW MASTER PLAN				
TITLE POWER AND TELECOM LAYOUT				
PROJECT No	SUBDIVISION	SUBJECT	SERIAL	REV.
627320	0000	40DK	0024	PA

